 

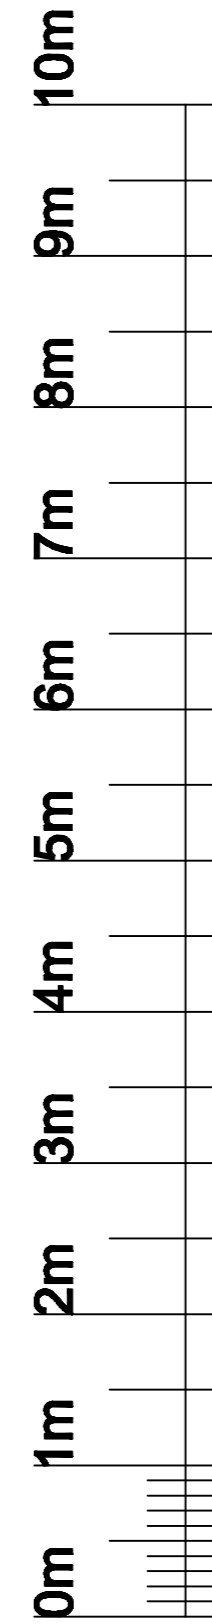


DESIGNER'S NOTES

KEY TO SYMBOLS

- TS TECH & GS SOCKET
- WB WALL BOX
-  CAMERA CABLE CONNECTION
- CYC RAIL
- FE FIRE EXTINGUISHER
-  LIGHTING OUTLETS



PRODUCER
DIRECTOR
DESIGNER
LIGHTING
ZERO DATE
PRODUCTION DATE

LIGHTING PLAN
METRIC STUDIO PLAN SCALE 1:50 @ A2

TC 12

PROGRAMME

